

1

Floor Plan

EVENT NAME:
INTERNATIONAL GREENBUILD AND RENEWABLE ENERGY EXHIBITION 2007

EVENT LOCATION:
AUSTRALIAN TECHNOLOGY PARK

EVENT DATE:
1 - 3 JUNE 2007

ORGANISED BY:
WSB MEDIA


DRAWING NO:
GREX-0607-104

DATE:
15 MAY 2007

SCALE:
NTS

SYSTEM: **FOGA**

PNLS: **BLACK**
 FASCIA: **WHITE ON GREEN**
 CARPET: **VENUE**
 LIGHTS: **2 X TRACK SPOTS**
 POWER: **1 X 10 AMP GPO**

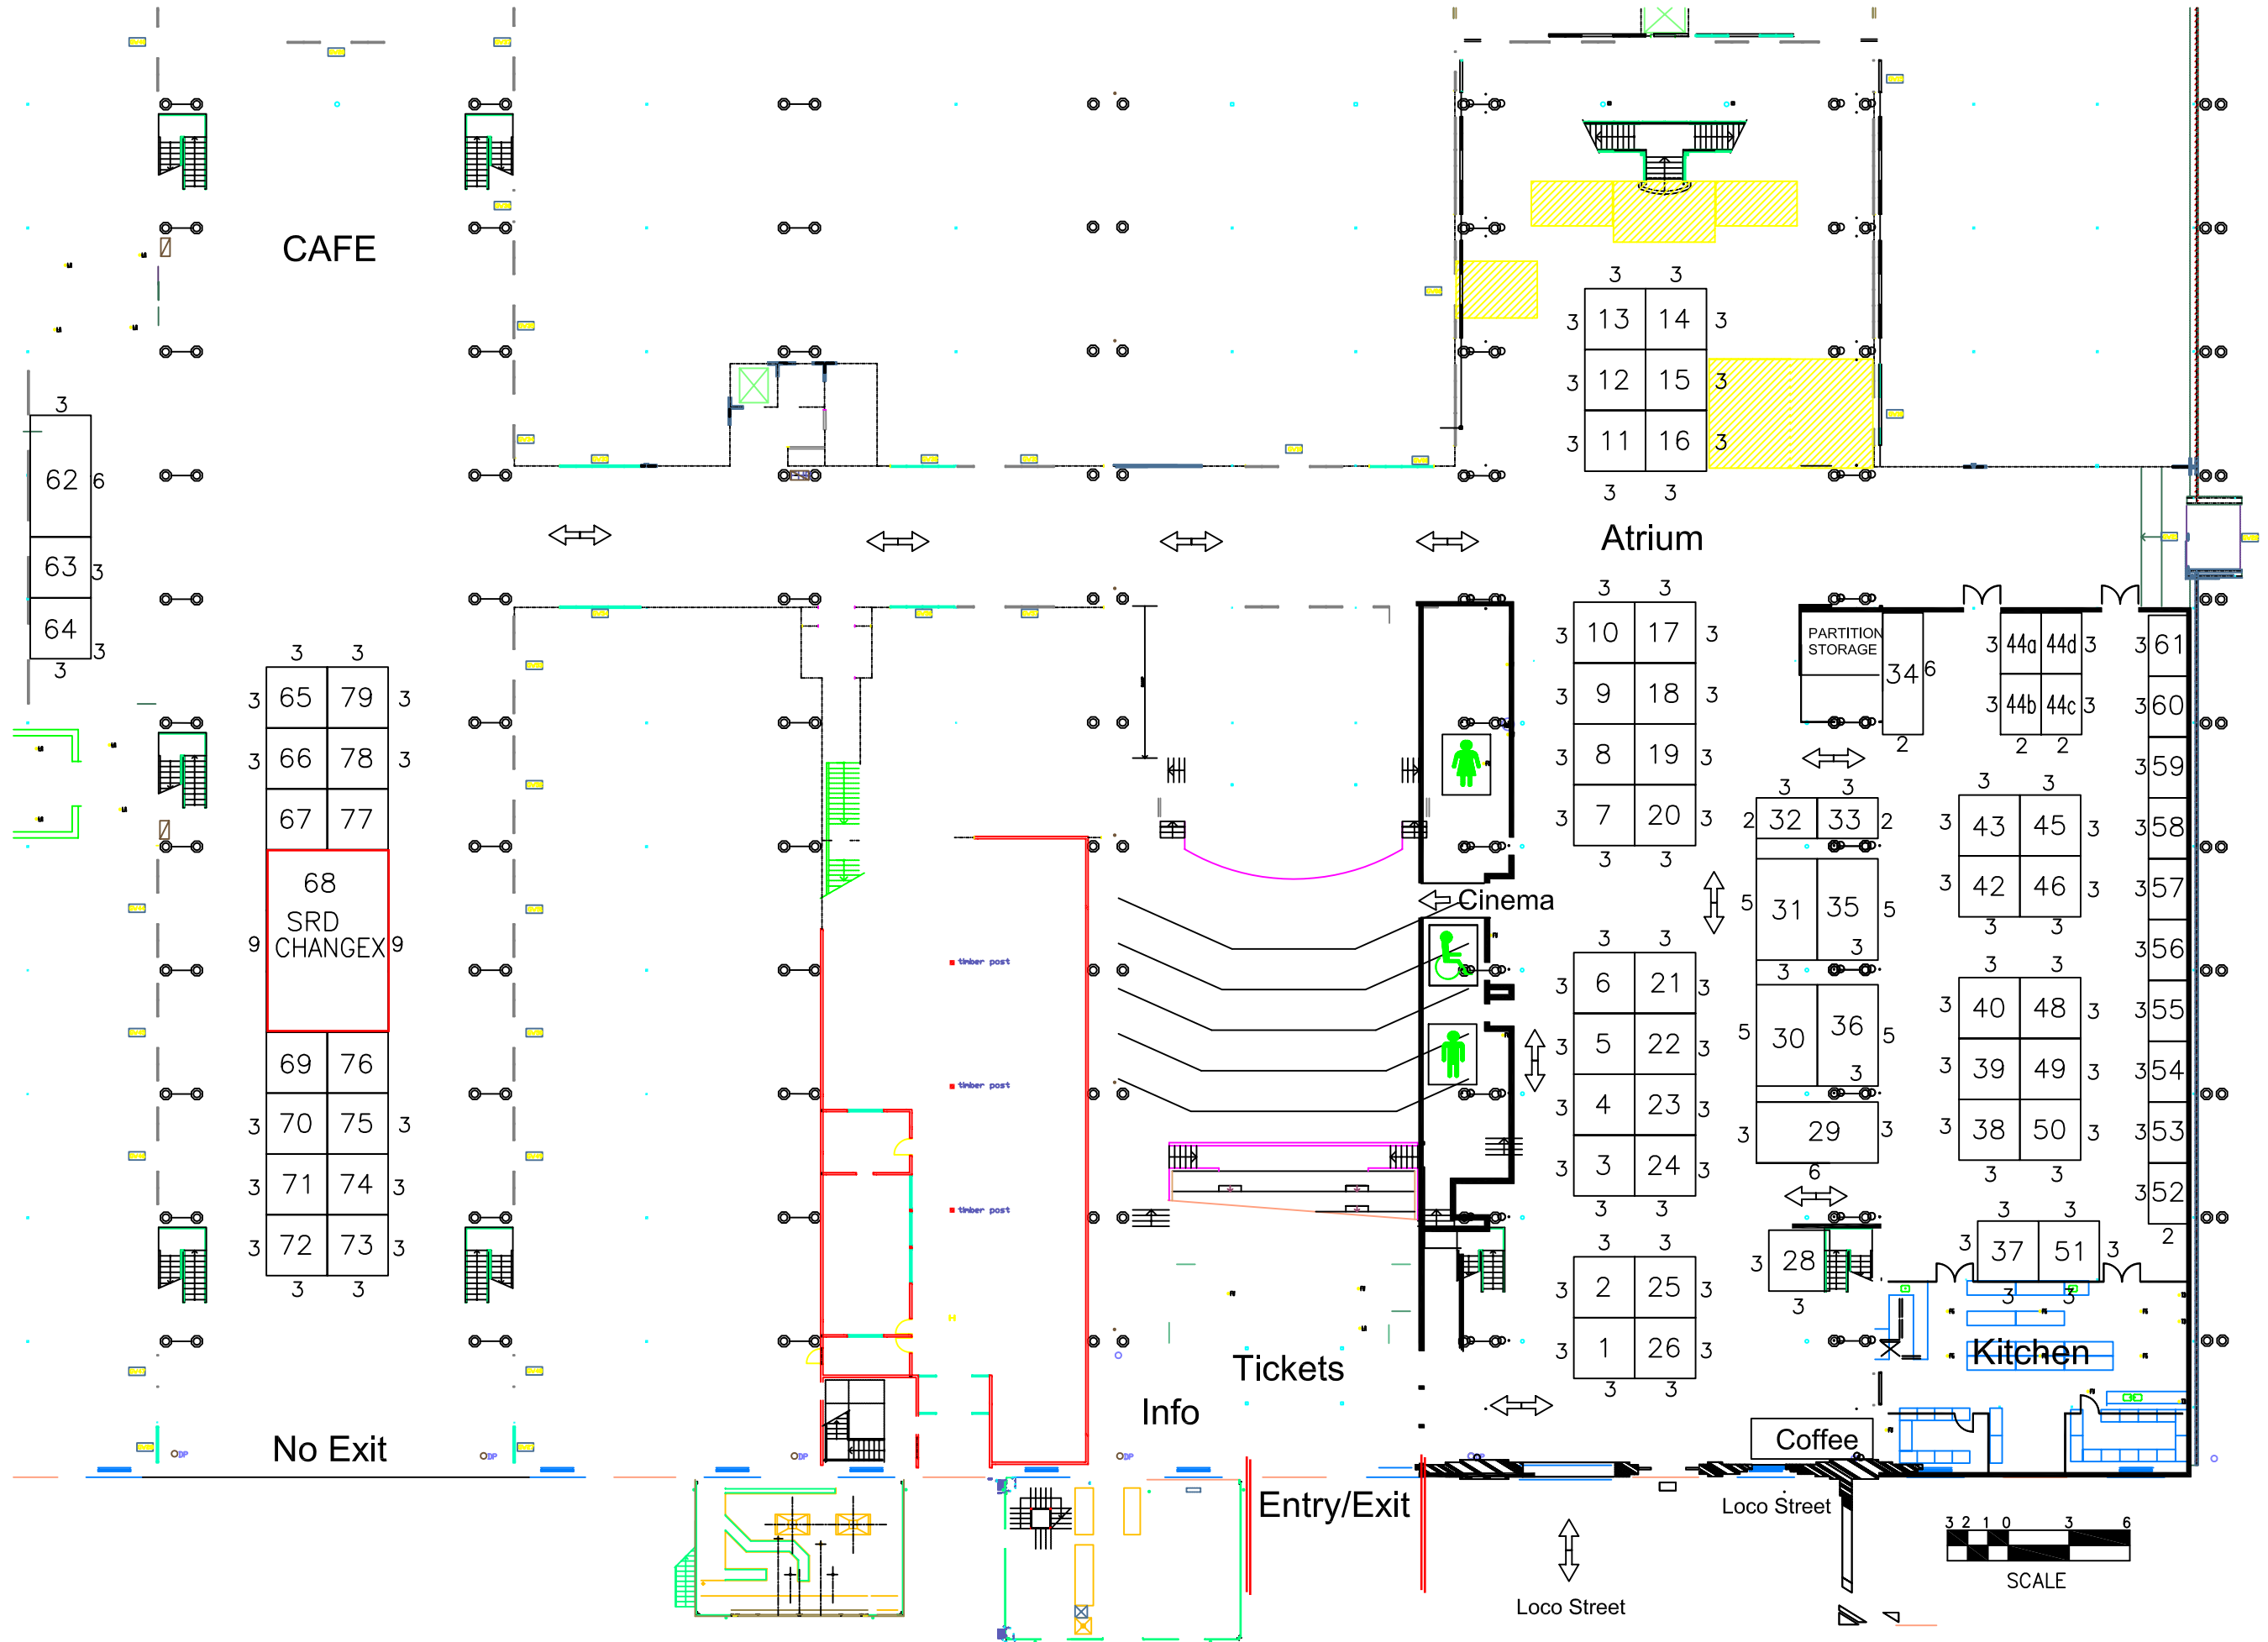

PO BOX 709
 BROOKVALE, NSW 2100
 Australia
 Ph. (02) 9982 5511
 Fax. (02) 9982 9899
 sales@exhibitsystems.com.au
 www.exhibitsystems.com.au